


# MALDON WATER SUPPLY

Scale, 40' = 1"

F. H. Ballantyne 20.1.22  
Chief Engineer of Way and Works

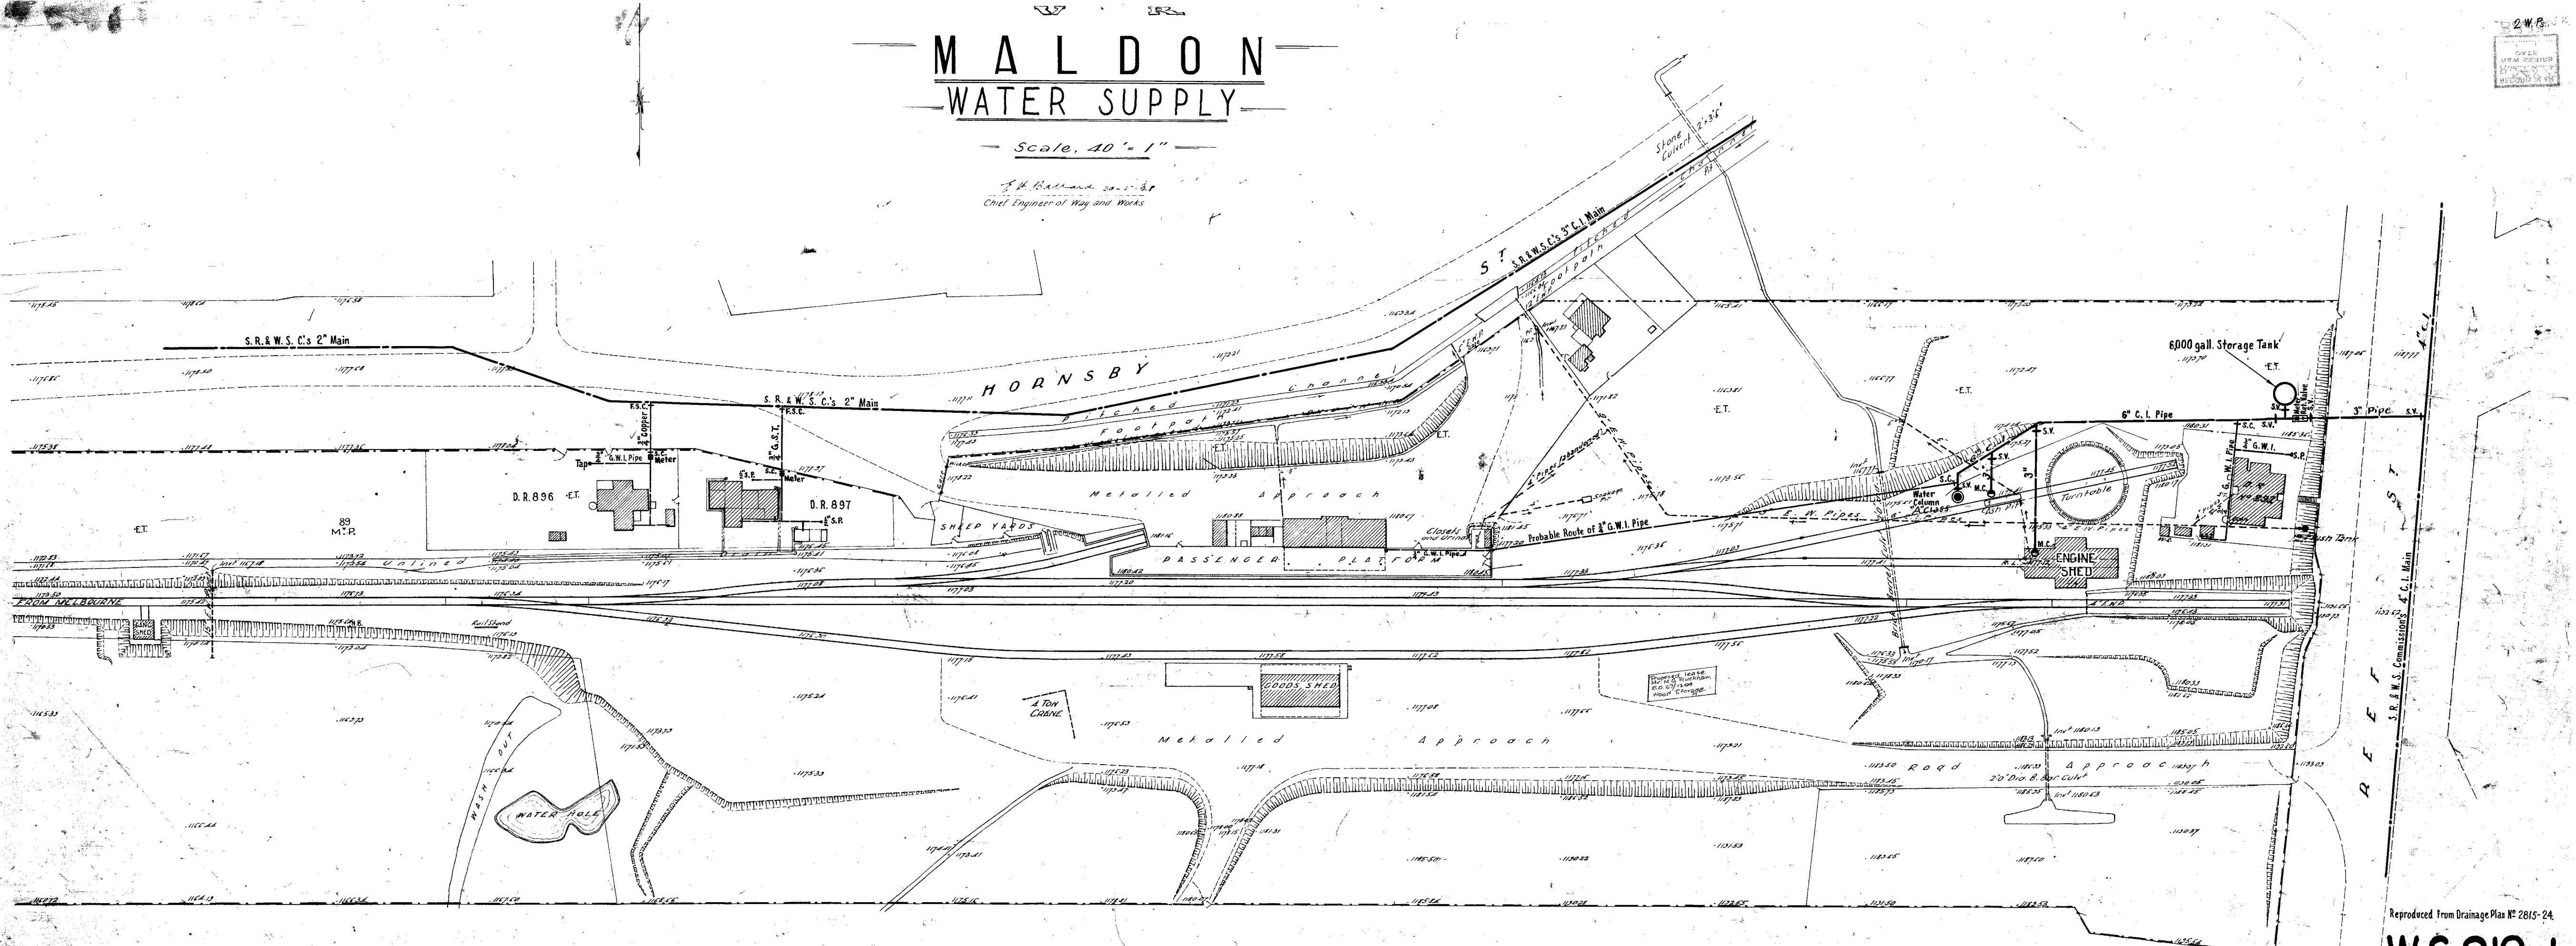

2 W.P.  
DRAWN BY  
CHECKED BY  
RECORDED BY

Reproduced from Drainage Plan No 2815-24.  
**W.S-218-1**  
**F-30**  
Plan No 458-62

Revision	Date	Amendment	Amended by	Eng' of M. & W.S.
A	14-9-62	Amended to information supplied by D.E.		A.A.P.